

GENERATOR HOUSE CONSTRUCTION

Sheet List

Sheet Number	Sheet Name
A-00	COVER PAGE
A-01	Floor Plan
A-01B	Structural Plans
A-01C	Elevations
A-02	Sections
A-03	Details

GENERATOR HOUSE CONSTRUCTION

MINISTRY OF
COMMUNICATIONS WORKS
& LABOUR

PWD

P.O. BOX 344, MONTSERRAT
TEL: (664) 491-6811 FAX: (664) 491-6659
EMAIL: COWARCH@GOV.MS



REVISIONS

DATE	Stamp
DRAWN BY:	Author
CHECKED BY:	Checker

COVER PAGE

SHEET NO.

A-00

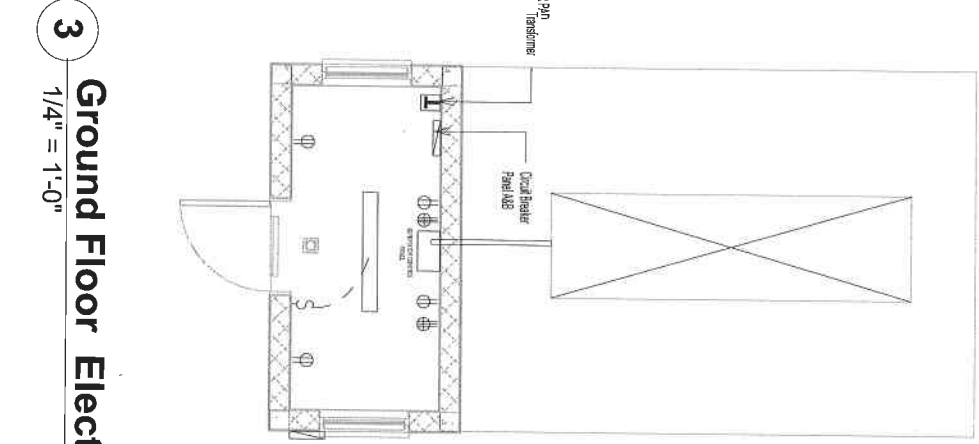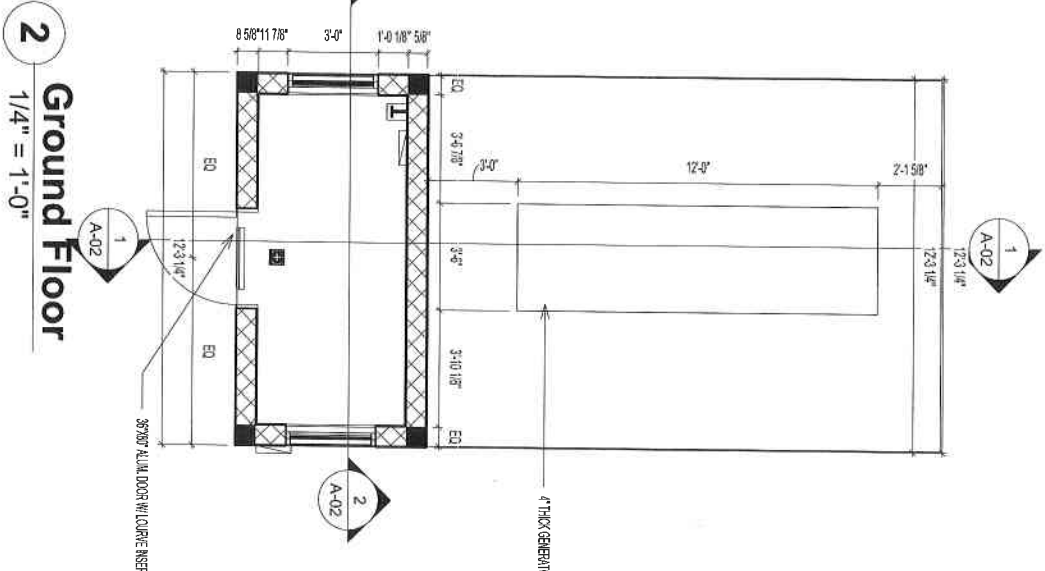

PANEL A CIRCUIT SCHEDULE (Ground Floor)

TYPE	SPN (TYPE A) B WAYS SINGLE PHASE ISOLATOR- 100A DP VOLTAGE: 240 VOLTS AC	DESCRIPTION: 200V POWER AND LIGHTING LOCATION: 2 Bed Unit SUPPLY FROM: ELECTRICITY METER SUPPLY CABLE LENGTH & SIZE = 16mm 2				
NO. OF CIRCUIT	DESCRIPTION	NO. OF POINTS	MCB RTG (A)	CABLE SIZE (mm 2)	EST. LENGTH (M)	EST. LOAD (A)
1	LIGHTS: room 1	2	5	1.5		10 Amps
2	TRANSFORMER	1	30	4.0		18 Amps
3						
4						
5						

PANEL B CIRCUIT SCHEDULE (Ground Floor)

TYPE	SPN (TYPE A) B WAYS SINGLE PHASE ISOLATOR- 100A DP VOLTAGE: 110 VOLTS AC	DESCRIPTION: 110V POWER LOCATION: 2 Bed Unit SUPPLY FROM: Panel A via Sine transformer SUPPLY CABLE LENGTH & SIZE = 16mm 2				
NO. OF CIRCUIT	DESCRIPTION	NO. OF POINTS	MCB RTG (A)	CABLE SIZE (mm 2)	EST. LENGTH (M)	EST. LOAD (A)
1	OUTLETS: room 1	4	20	2.5		20 Amps
2						
3						

MINISTRY OF COMMUNICATIONS WORKS & LABOUR
 or copyright and/or trademark and property rights therein, no rights are
 transferred or conveyed because of model or design of any part of the
 document or use, in any form, without written permission of MINISTRY OF COMMUNICATIONS WORKS & LABOUR.

REVISIONS

NO.	DATE	BY	REASON


Floor Plan
 SHEET NO. **A-01**

PWD


MINISTRY OF
 COMMUNICATIONS WORKS
 & LABOUR

P.O. BOX 344, MONTSERRAT
 TEL: (664) 461-4611 FAX: (664) 461-4669
 EMAIL: COW@RCOMGOV.MS


GENERATOR HOUSE CONSTRUCTION

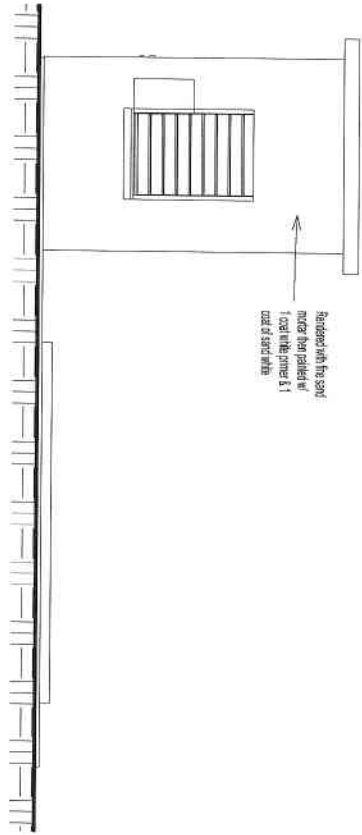


1
1/4" = 1'-0"

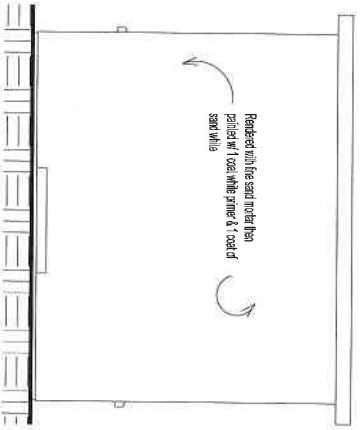

2
1/4" = 1'-0"

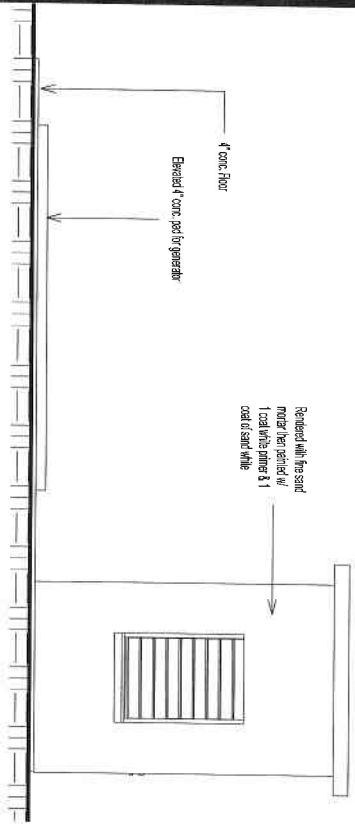

3
1/4" = 1'-0"

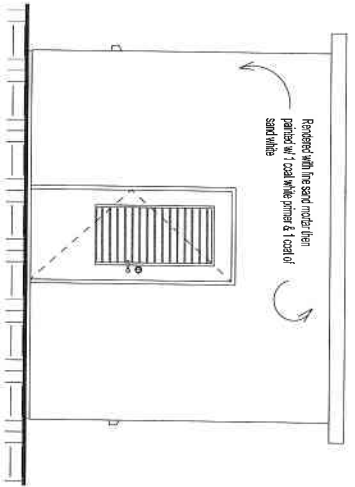

4
1/4" = 1'-0"


MINISTRY OF COMMUNICATIONS WORKS & LABOUR
 The design and construction of this project is the responsibility of the contractor. The design is not to be used for any other project without the written permission of the Ministry of Communications Works & Labour.

GENERATOR HOUSE CONSTRUCTION


PWD
 MINISTRY OF COMMUNICATIONS WORKS & LABOUR
 P.O. BOX 344, MONTERRAT
 TEL: (664) 494-6511 / FAX: (664) 491-6659
 EMAIL: GOVARCH@GOV.MS

REVISIONS	
DATE	Drawn By
DATE	Checked By
DATE	Approved By
DATE	Checked By
DATE	Checked By
DATE	Checked By
DATE	Checked By
DATE	Checked By
DATE	Checked By
DATE	Checked By

Elevations
 SHEET NO. **A-01C**

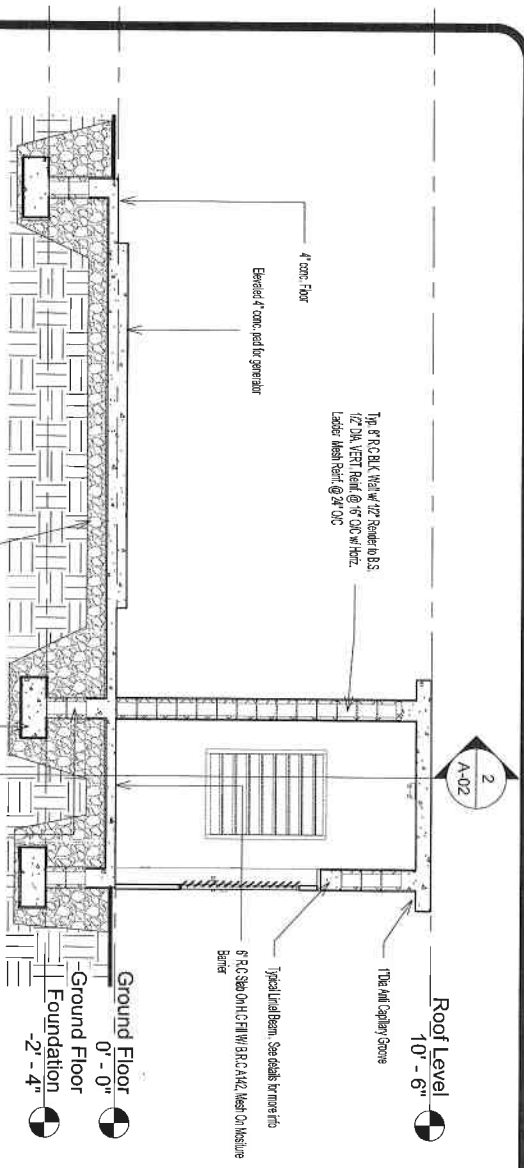

1
Section 1
1/4" = 1'-0"

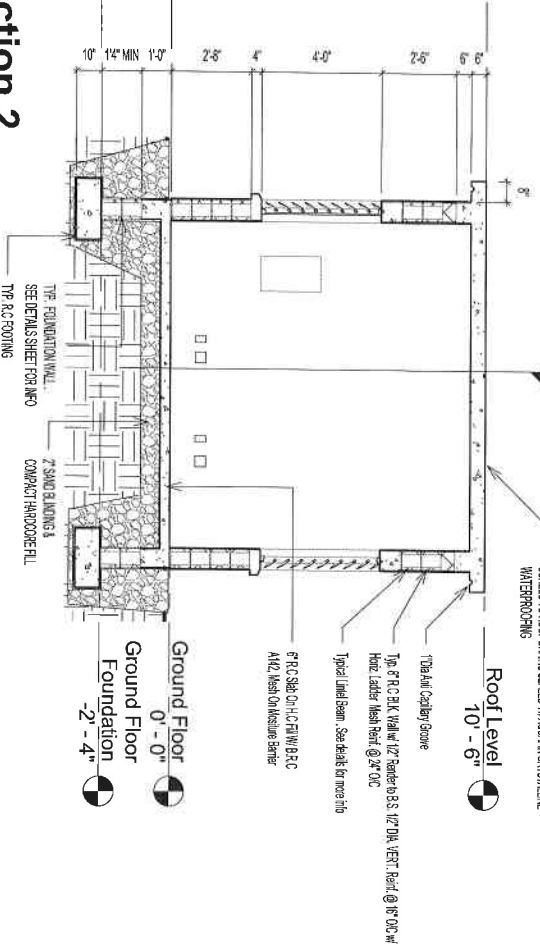

2
Section 2
1/4" = 1'-0"

MINISTRY OF COMMUNICATIONS WORKS & LABOUR
 Considers the subject matter in this document confidential and reserves copyright and property rights thereon. No rights are transferred or conveyed because of receipt or possession. It is either published to reproduce or change any part of the document or use it for any purpose without written permission of MINISTRY OF COMMUNICATIONS WORKS & LABOUR.

REVISIONS	

DATE			
DRAWN BY		Autor	
CHECKED BY			

Sections	
SHEET NO.	A-02

PWD

MINISTRY OF
COMMUNICATIONS WORKS
& LABOUR

P.O. BOX 344, MONTSERRAT
TEL: (868) 491-6611 / FAX: (868) 491-6659
EMAIL: COMARCH@GOV.MS

GENERATOR HOUSE CONSTRUCTION

